

**CITY OF CALEXICO
BUILDING DEPARTMENT**

**CONSTRUCTIVE PLANS EXAMPLE FOR MINOR BUILDING PROJECT
[PATIO ADDITION (S)]**

PLANS TO BE INCLUDED:

1. SITE PLAN
2. FLOOR PLAN
3. ELEVATION
4. FOOTING PLAN
5. FRAMING PLAN & STRUCTURAL DETAILS

NOTE: EVERY PLANS TO BE INCLUDED SCALE, NORTH & CLARITY READING

REVISIONS:

PROJECT: PROPOSED ADDITION PATIO



ADDRESS: NUMBER, STREET, CITY & STATE

SITE PLAN

DRAWN BY:

DATE:

SCALE: 1"=10'-0"

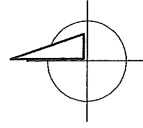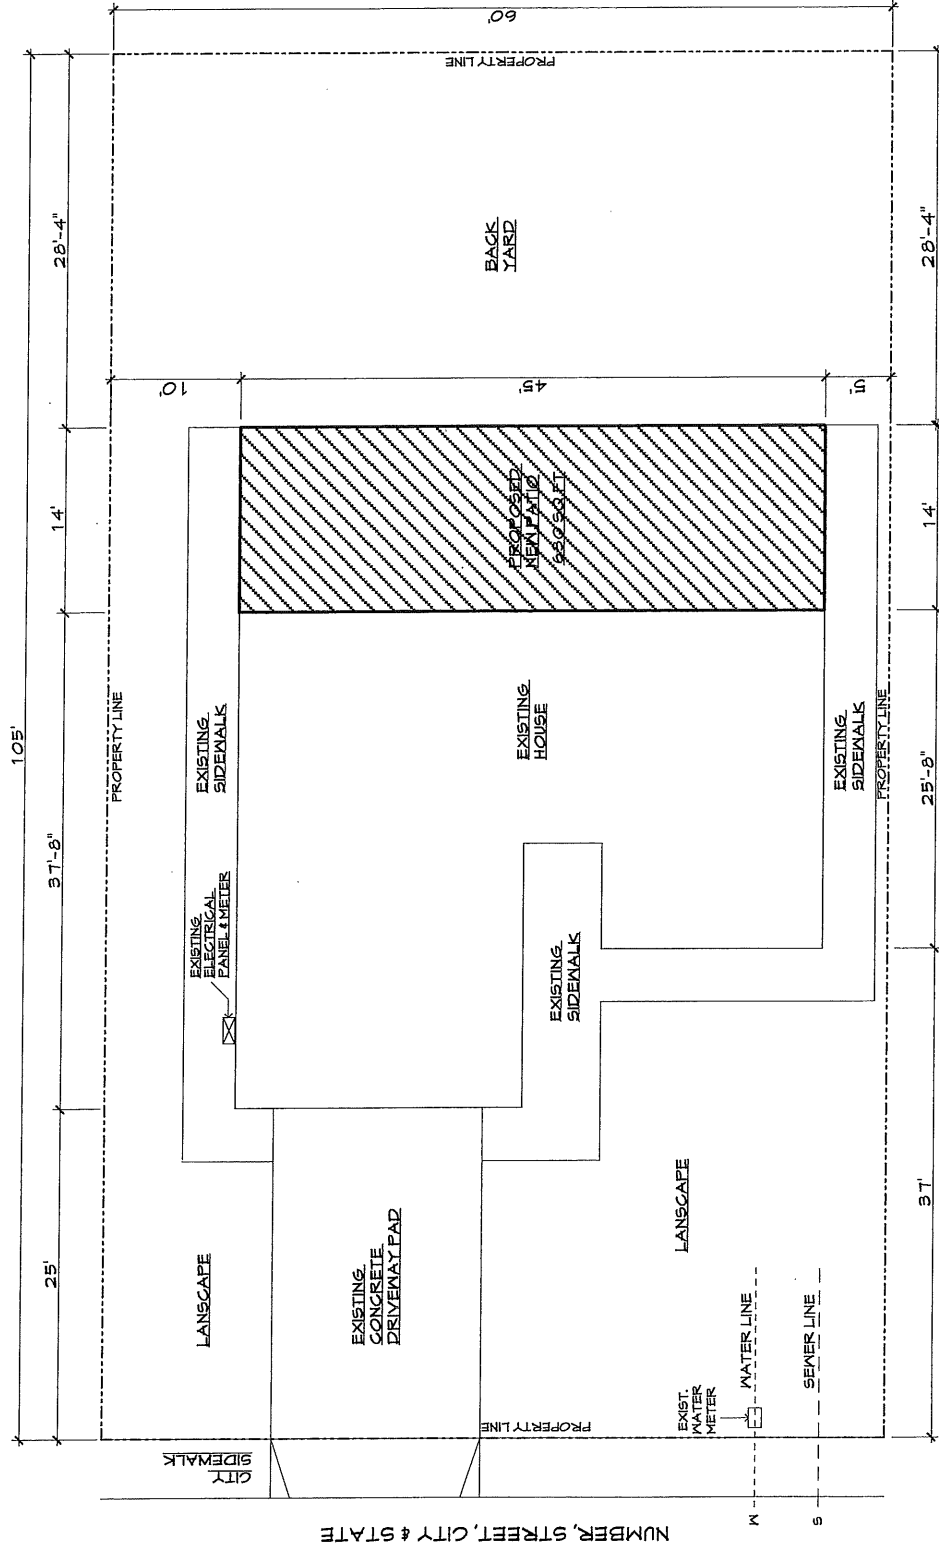

SCALE=1"=10'-0"

SITE PLAN

REVISIONS:


PROJECT: PROPOSED ADDITION PATIO
ADDRESS: NUMBER, STREET CITY & STATE

FLOOR PLAN & ELEVATION

PLAN: DRAWN BY: DATE:


SCALE: 1/8"=1'-0"

A-2

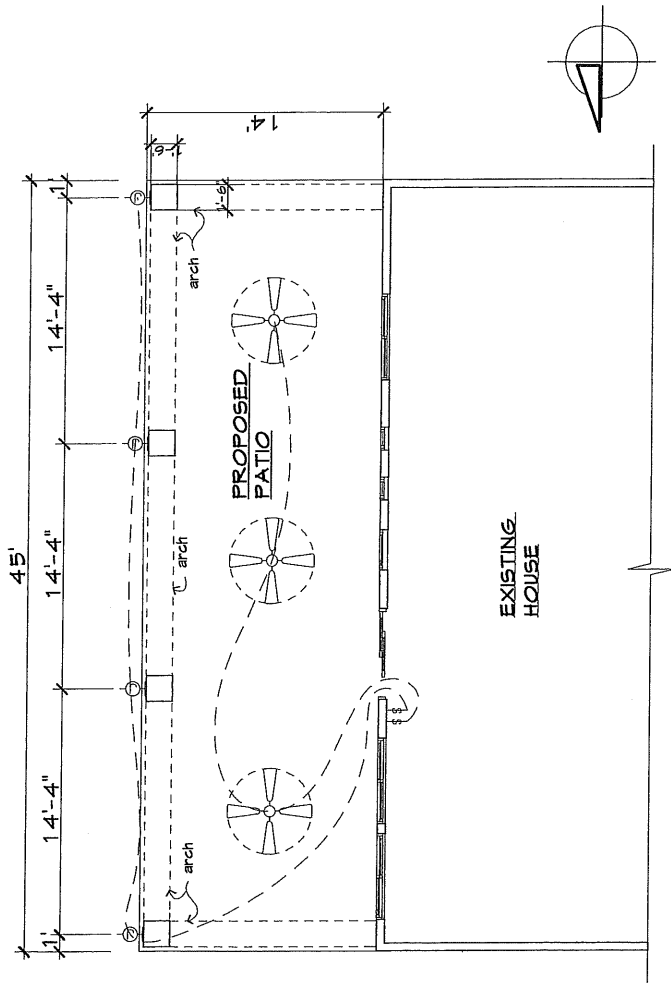

FLOOR PLAN

SCALE=1/8"=1'-0"

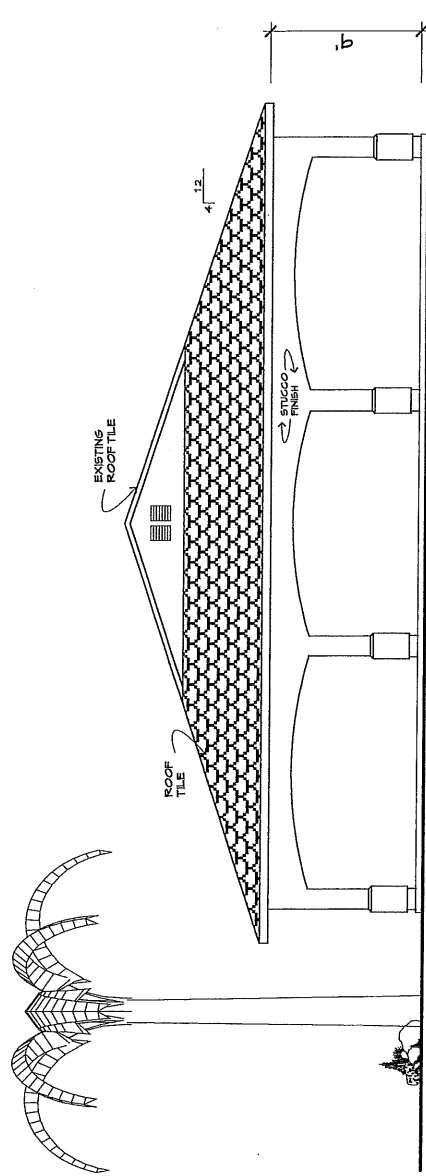

EAST ELEVATION

SCALE=1/8"=1'-0"

NOTE

NEW CONSTRUCTION SHALL COMPLY THE 2001 CALIFORNIA BUILDING, PLUMBING, MECHANICAL & ELECTRICAL CODES

CONSTRUCTION AREA

PATIO = 630 sq ft

ELECTRICAL LEGEND

⚡	switch coupled
⊕	outlet wall fixture
⊗	ceiling fan light

REVISIONS:

PROJECT: PROPOSED ADDITION PATIO

ADDRESS: NUMBER, STREET, CITY & STATE

FOOTING PLAN


PLAN

DRAWN BY:

DATE:

SCALE: 1/8" = 1'-0"


A-3

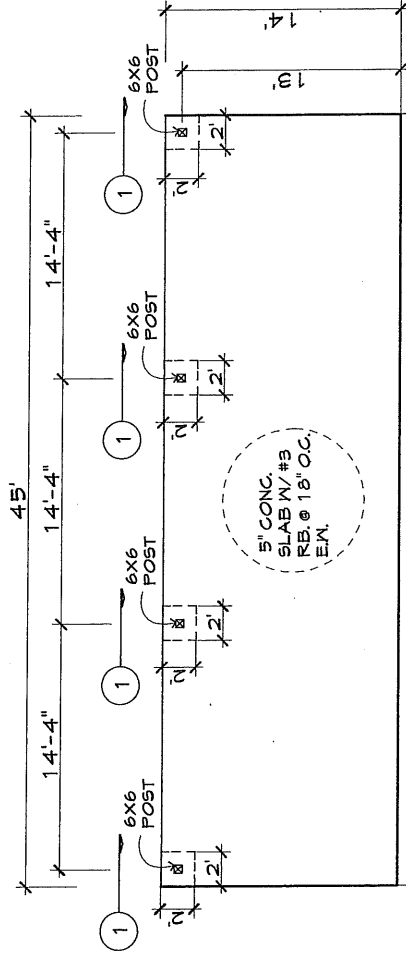


FOOTING PLAN

SCALE=1/8"=1'-0"

FOOTING DETAILS

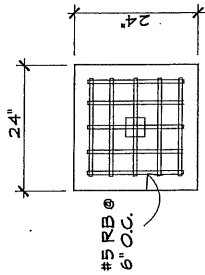


PLAN VIEW

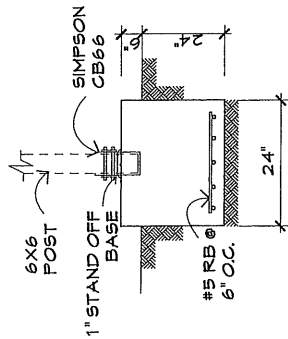


SECTION VIEW

FOOTING 1

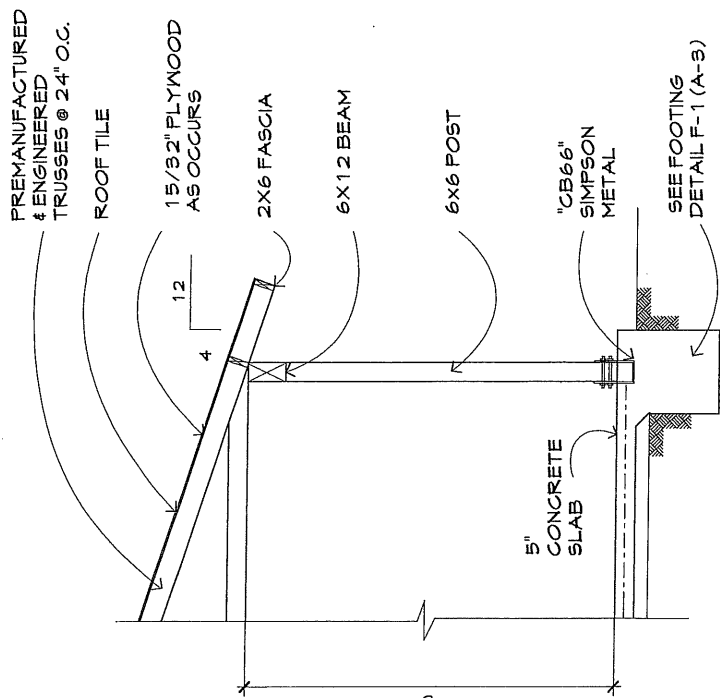


SECTION S-1

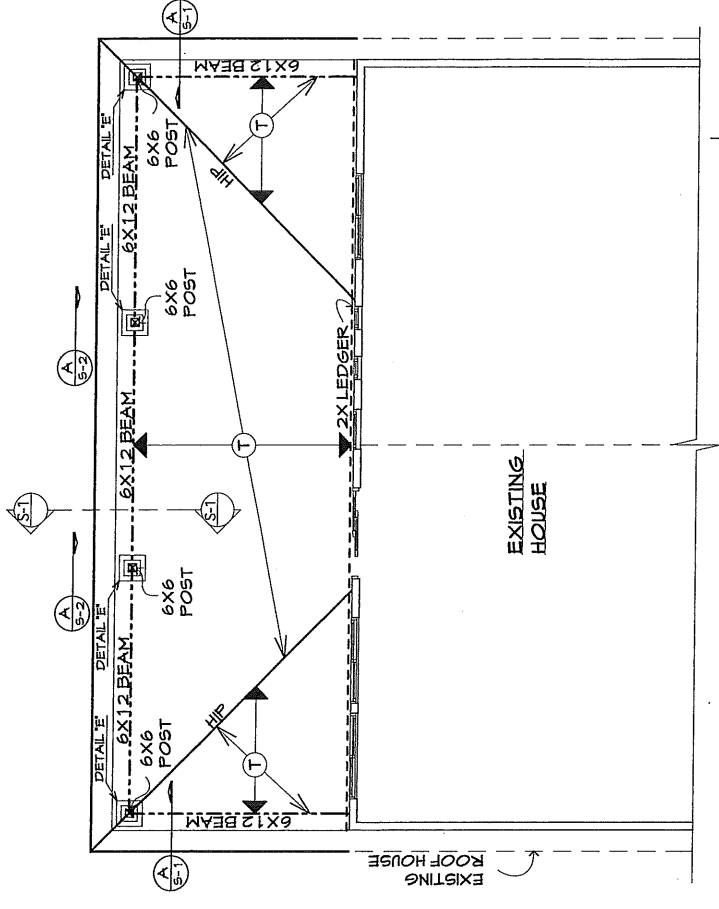

FRAMING PLAN

SCALE=1/8"=1'-0"

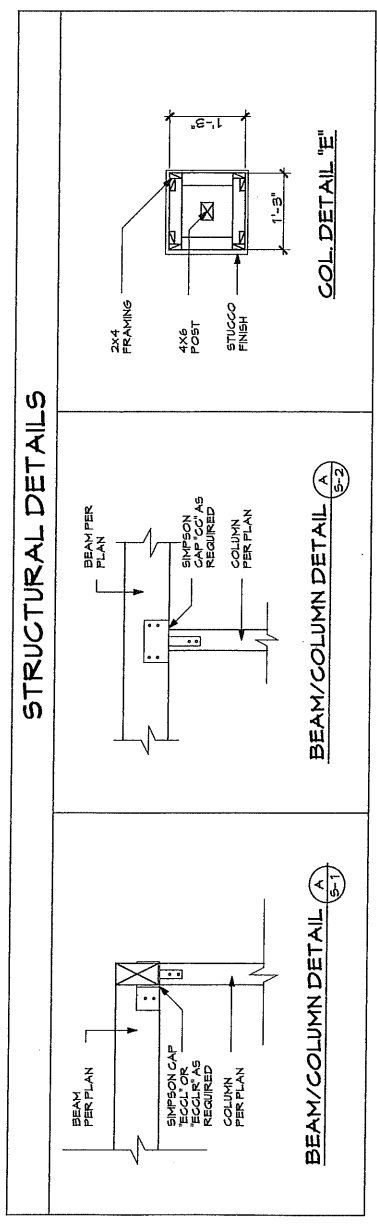

LEGEND
PREMANUFACTURED & ENGINEERED TRUSSES @ 24" O.C.
(T)

NOTE
1/2" OSB ROOF SHEATHING & 1/2" CCX ON OVERHANGS

A-4

FRAMING PLAN & STRUCTURAL DETAILS

PROPOSED ADDITION PATIO

PROJECT: ADDRESS: NUMBER, STREET, CITY & STATE

PLANS
DRAWN BY:
DATE:
SCALE: 1/8"=1'-0"

REVISIONS: